

**CLEARCHANNEL RADIO
 TRANSMITTER
 BUILDING ADDITIONS**
 LAKE COUNTY, FLORIDA

FOR:
CLEARCHANNEL RADIO
 2500 Maitland Center Pkwy.
 Suite 401
 Maitland, Florida 32751

General Notes


Mark Date Revision

Project No: 05-355 Approv. By: RLB
 Drawn By: RON Date: 5/12/05
 Checked By: RLB Scale: NOTED

**TRANSMITTER
 BUILDING
 FLOOR PLAN**

Sheet No:

A-2

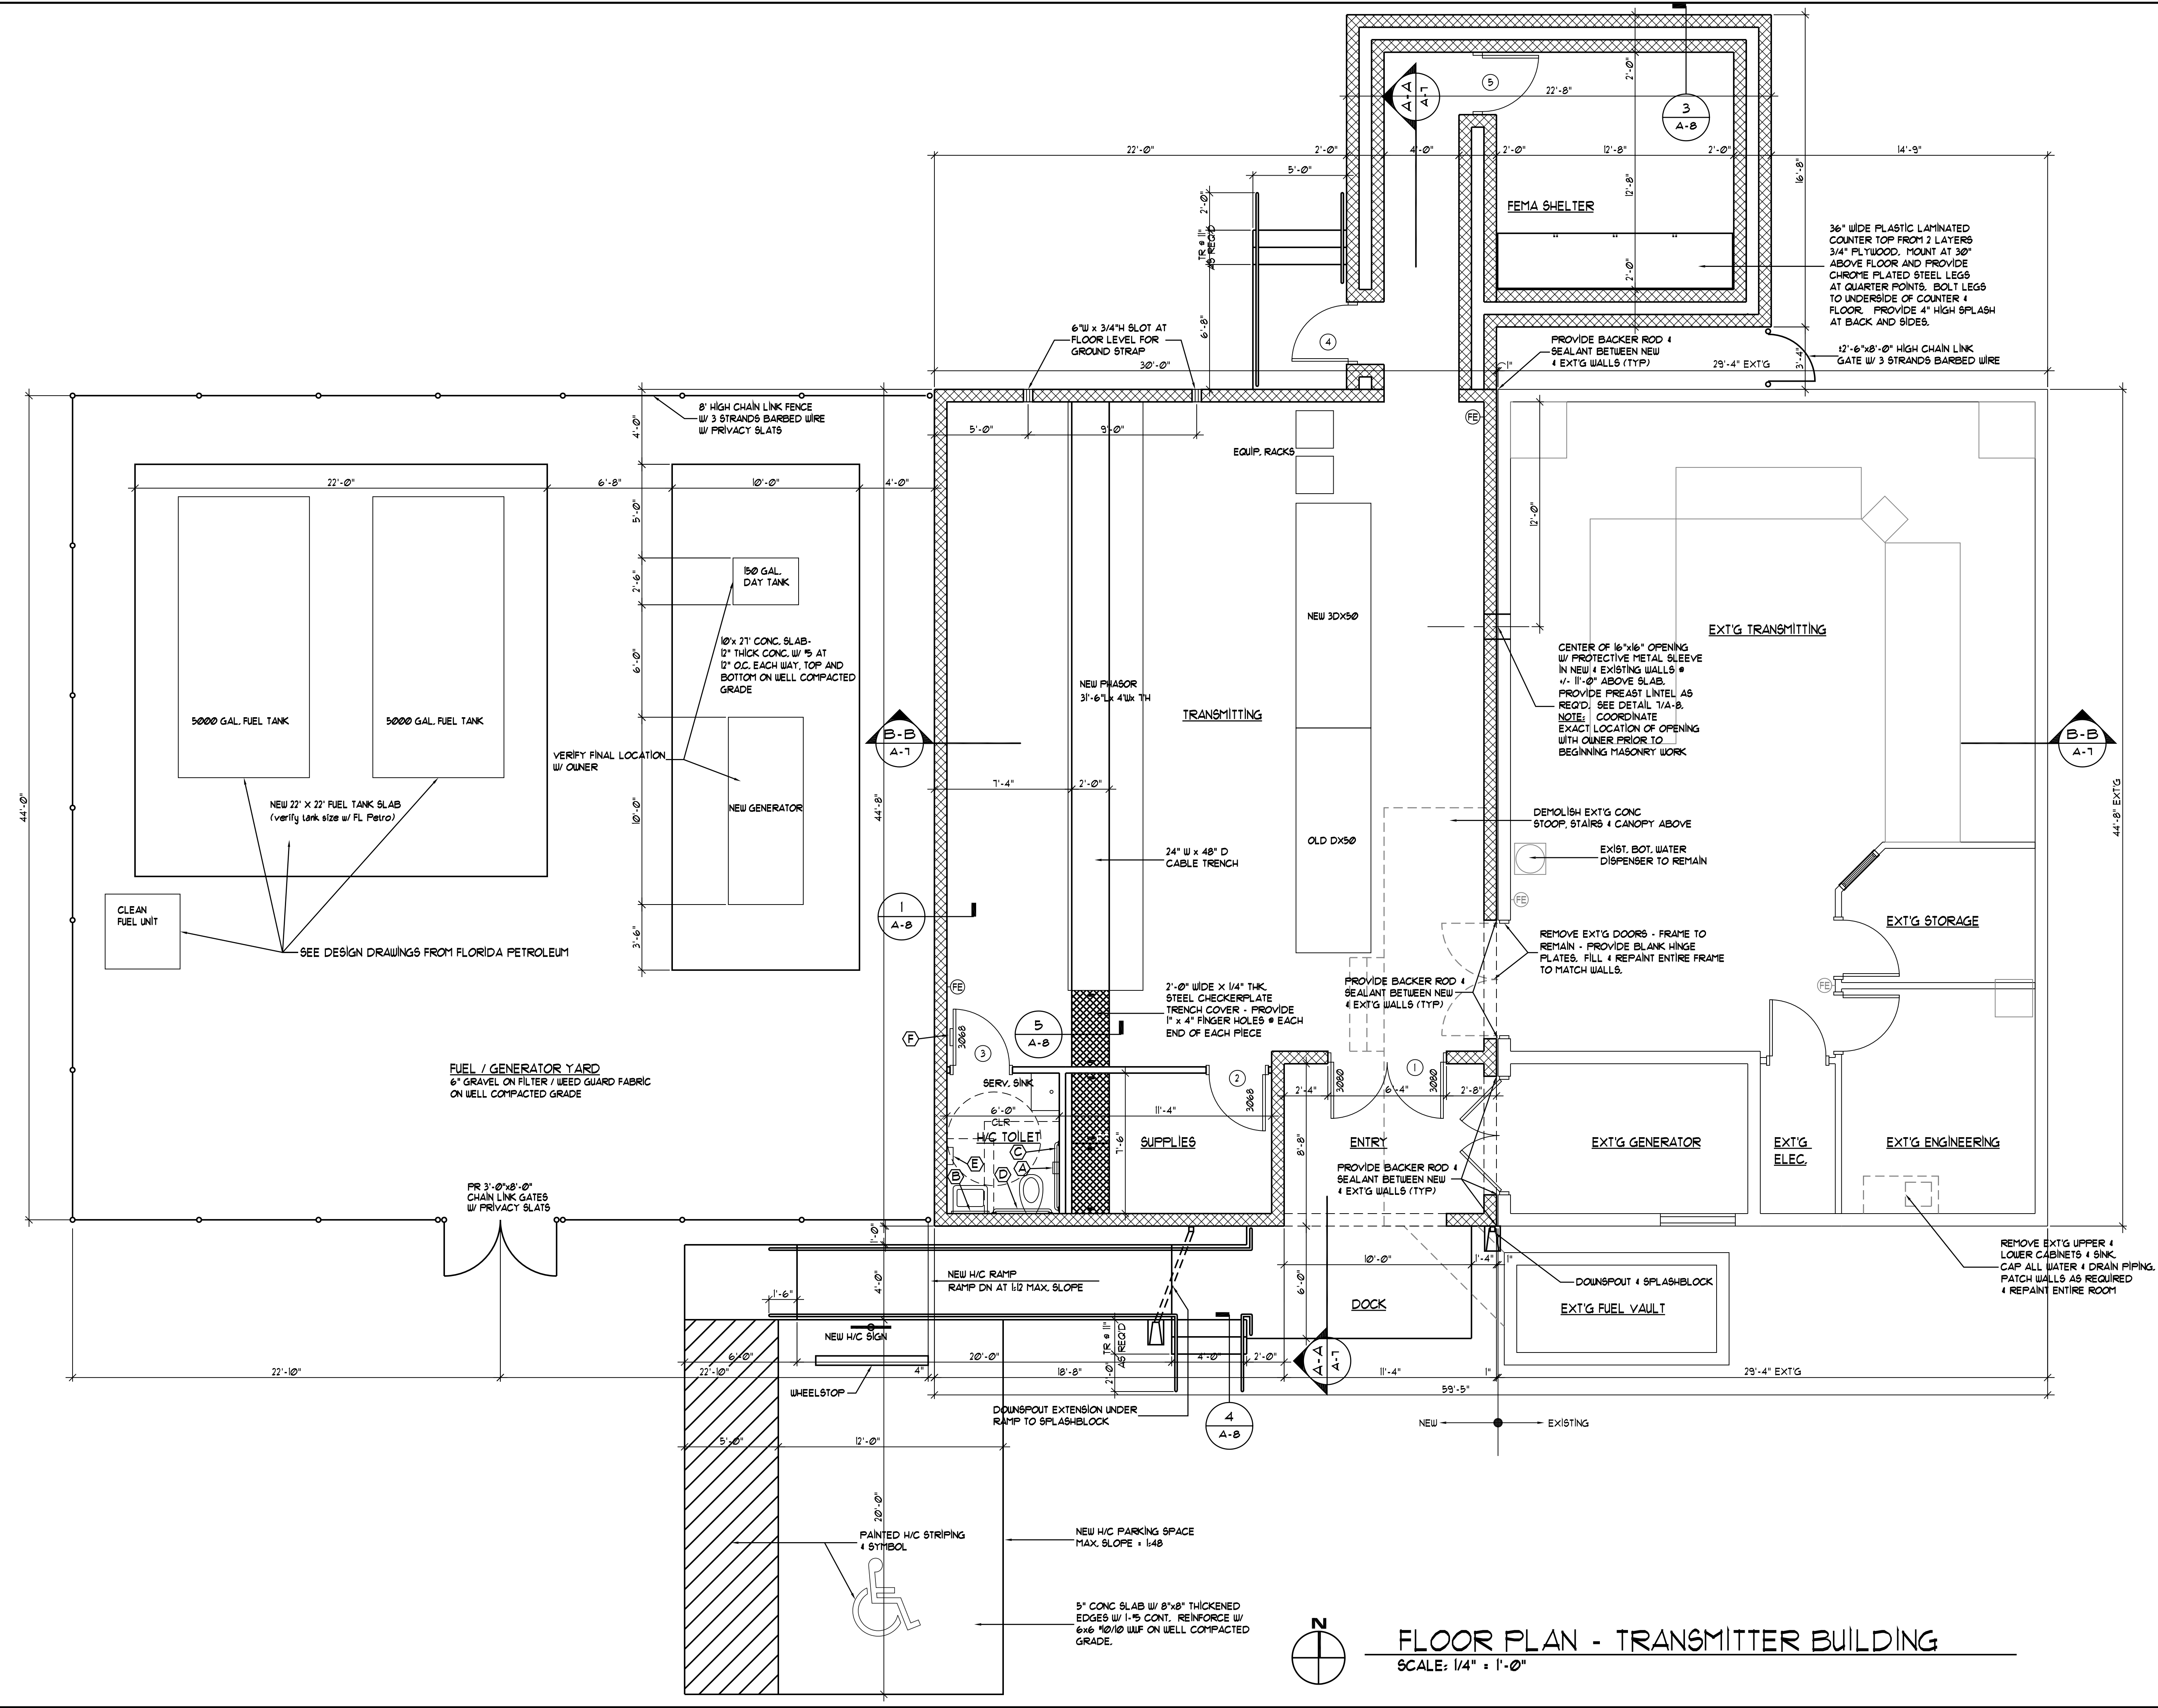

FLOOR PLAN - TRANSMITTER BUILDING
 SCALE: 1/4" = 1'-0"